


REFLECTED CEILING PLAN - AREA "B"  
SCALE: 1/8" = 1'-0"

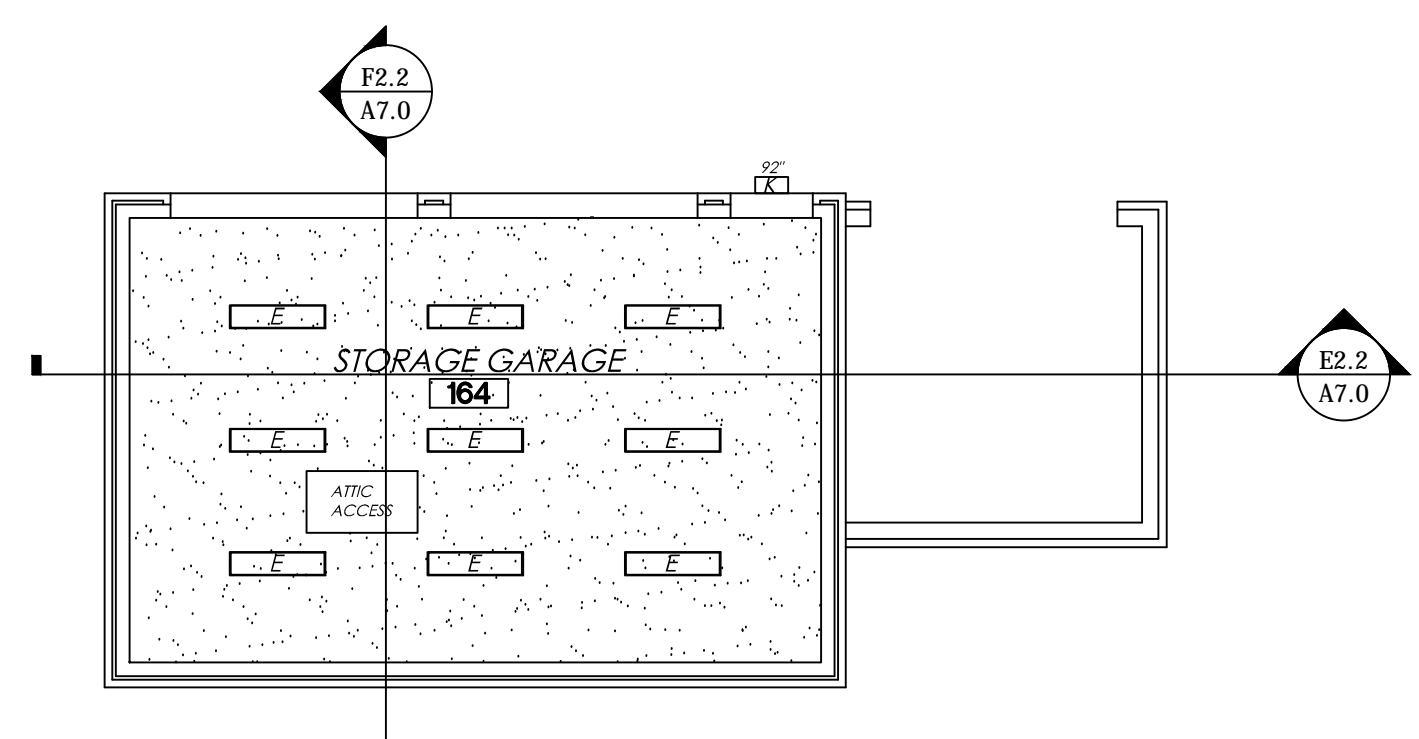

REFLECTED CEILING PLAN - STORAGE GARAGE  
SCALE: 1/8" = 1'-0"

**REFLECTED CEILING LEGEND**


- NON-LOAD BEARING WALL TO TERMINATE INTO CEILING STRUCTURE ABOVE
- 1 HR. FIREWALL - WALL TO TERMINATE INTO ROOF SUPPORTS ABOVE (UL DESIGN NO. U305)
- 2 HR. FIREWALL - WALL TO TERMINATE INTO ROOF STRUCTURE ABOVE (UL DESIGN NO. U301)
- STRUCTURAL HEADER (SEE STRUCT. DWGS.)
- 1/2" GYPSUM CEILING ON CEILING JOISTS @ 10'-0" A.F.F.
- FIBERGLASS REINFORCED PANEL CEILING @ 10'-0" A.F.F.
- 1 HR. FIRE RATED CEILING (UL DESIGN NO. L504)
- INDOOR / OUTDOOR CEILING FAN WITH BUILT-IN LIGHT FIXTURE

**LIGHT FIXTURE LEGEND**

- A 8" COMPACT FLOURESCENT CYLINDER, VERTICAL LAMP WITH 6" APERTURE, DIMMABLE SURFACE MOUNTED DOWNLIGHT (MOUNTED ON SLOPED CEILING)
- B 6" COMPACT FLOURESCENT DOWNLIGHT, VERTICAL LAMP WITH 6" APERTURE, RECESSED MOUNTED DOWNLIGHT (IC-RATED) IN CONTACT WITH INSULATION ABOVE CEILING
- C 1x4' - (2) T8 LAMPS, VOLUMETRIC LUMINAIRE WITH CENTER DIFFUSER, RECESSED MOUNTED LUMINAIRE (IC-RATED) IN CONTACT WITH INSULATION ABOVE CEILING
- D 2x4' - (4) T8 LAMPS, CLEANROOM, SEALED RECESSED MOUNTED LUMINAIRE (NSF-RATED) (IC-RATED) IN CONTACT WITH INSULATION ABOVE CEILING
- E 1x4' - (3) T8 LAMPS, LENSED LUMINAIRE WITH GASKET, RECESSED MOUNTED LUMINAIRE (IC-RATED) IN CONTACT WITH INSULATION ABOVE CEILING
- F (7) LEDS, LOW WATTAGE, DIMMABLE LED TRACK FIXTURE (SURFACE MOUNTED TRACK)
- G LED, LOW WATTAGE, DIMMABLE, LOUVERED STEP LIGHT, RECESSED WALL LUMINAIRE
- H LED, LOW WATTAGE, EXIT AND EMERGENCY COMBO, WALL MOUNTED FIXTURE
- I (3) LEDS, LOW WATTAGE, OUTDOOR EGRESS LUMINAIRE, SURFACE MOUNTED FIXTURE
- J CERAMIC METAL HALIDE, EXTERIOR WALL PACK, SURFACE MOUNTED FIXTURE


**GENERAL RCP NOTES:**

- ALL FIXTURE HEIGHTS INCLUDED ON THIS SHEET ARE FROM FINISH FLOOR TO THE BOTTOM OF EACH FIXTURE.
- CONTRACTOR TO COORDINATE ALL WALL LOCATIONS, HEIGHTS & THICKNESSES WITH STRUCTURAL DRAWINGS. CONTRACTOR TO ALSO COORDINATE ALL ATIC ACCESS LOCATIONS, HEADER LOCATIONS & SIZES WITH THE STRUCTURAL DRAWINGS.
- CONTRACTOR TO COORDINATE CEILING HEIGHTS IN GREAT ROOMS AND MULTI-PURPOSE ROOM WITH STRUCTURAL DRAWINGS.
- REFER TO MEP DRAWINGS FOR MORE DETAILED SPECIFICATIONS & REQUIREMENTS ON LIGHTING FIXTURES.
- ALL PENETRATIONS THROUGH 1 & 2 HOUR FIREWALLS AND 1 HOUR RATED CEILINGS NEEDS TO BE FIRE SEALED PER CODE TO MAINTAIN THE INTEGRITY OF THE FIRE ASSEMBLY.
- CONTRACTORS TO COORDINATE FAN & LIGHT INSTALLATION AS NECESSARY TO PREVENT OR MINIMIZE THE AMOUNT OF LIGHT STROBING IN ALL GREAT ROOMS AND THE MULTI-PURPOSE ROOM.

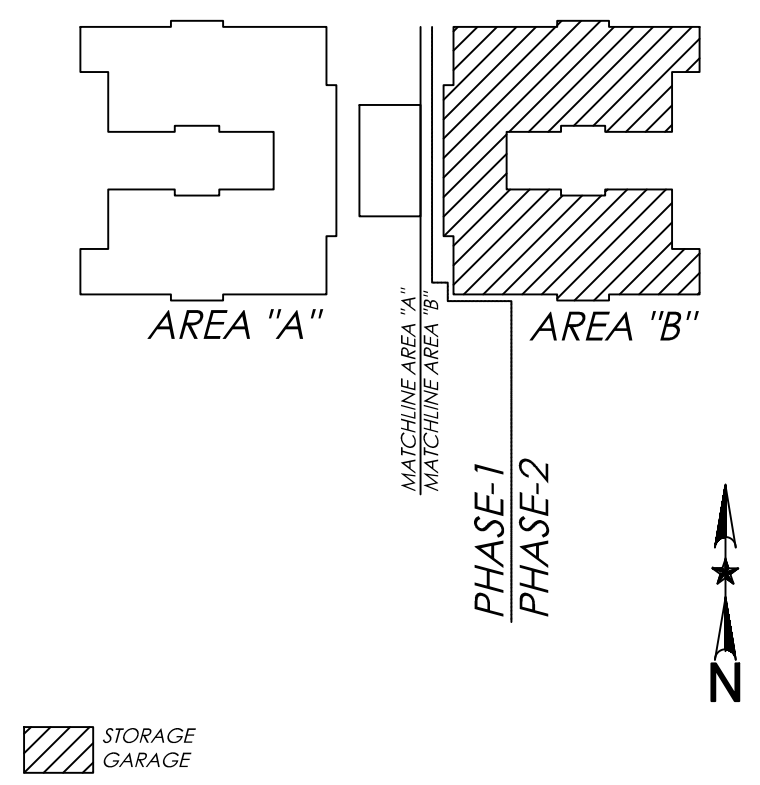

KEY PLAN  
SCALE: N.T.S.

**Optimum Personal Care  
Assisted Living Facilities**  
1110/12/14 Lakeview Dr.  
Sugar Land, Texas 77478

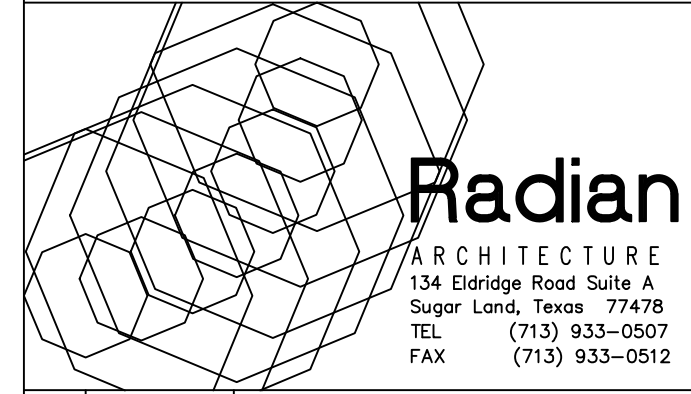

#	Date	Description
1	12.10.12	SCHEMATIC DESIGN
2	02.28.13	50% CONSTRUCTION DOCS.
3	05.30.13	CONTRACTOR SET
4	08.14.13	CONTRACTOR SET - #2
5	08.30.13	PERMIT / TDADS SETS
6	09.10.13	ACI CHANGES
7	11.25.13	TDADS COMMENTS
8	12.10.13	CITY COMMENTS
9	01.23.14	CITY COMMENTS
10	07.17.14	DOORS/WINDOWS REV.
11	08.20.14	FIRE SCREEN WALL
12	10.14.14	PERMIT SET #2
13	07.07.15	GREAT RM. MILLWORK
14	08.07.15	MILLWORK CLARIFICATION
15	08.31.15	COURTYARD REPLACEMENT



Project No. 1201.31

REFLECTED CEILING PLAN

Sheet No.

**A4.1**