



File Name: M:\Radian Architecture\12523.00 Optimum Care - Sugar Land\Plumb\12523.00 PLUMBING.rvt
 User: Author
 Date/Time: 4/8/2013 4:28:17 PM

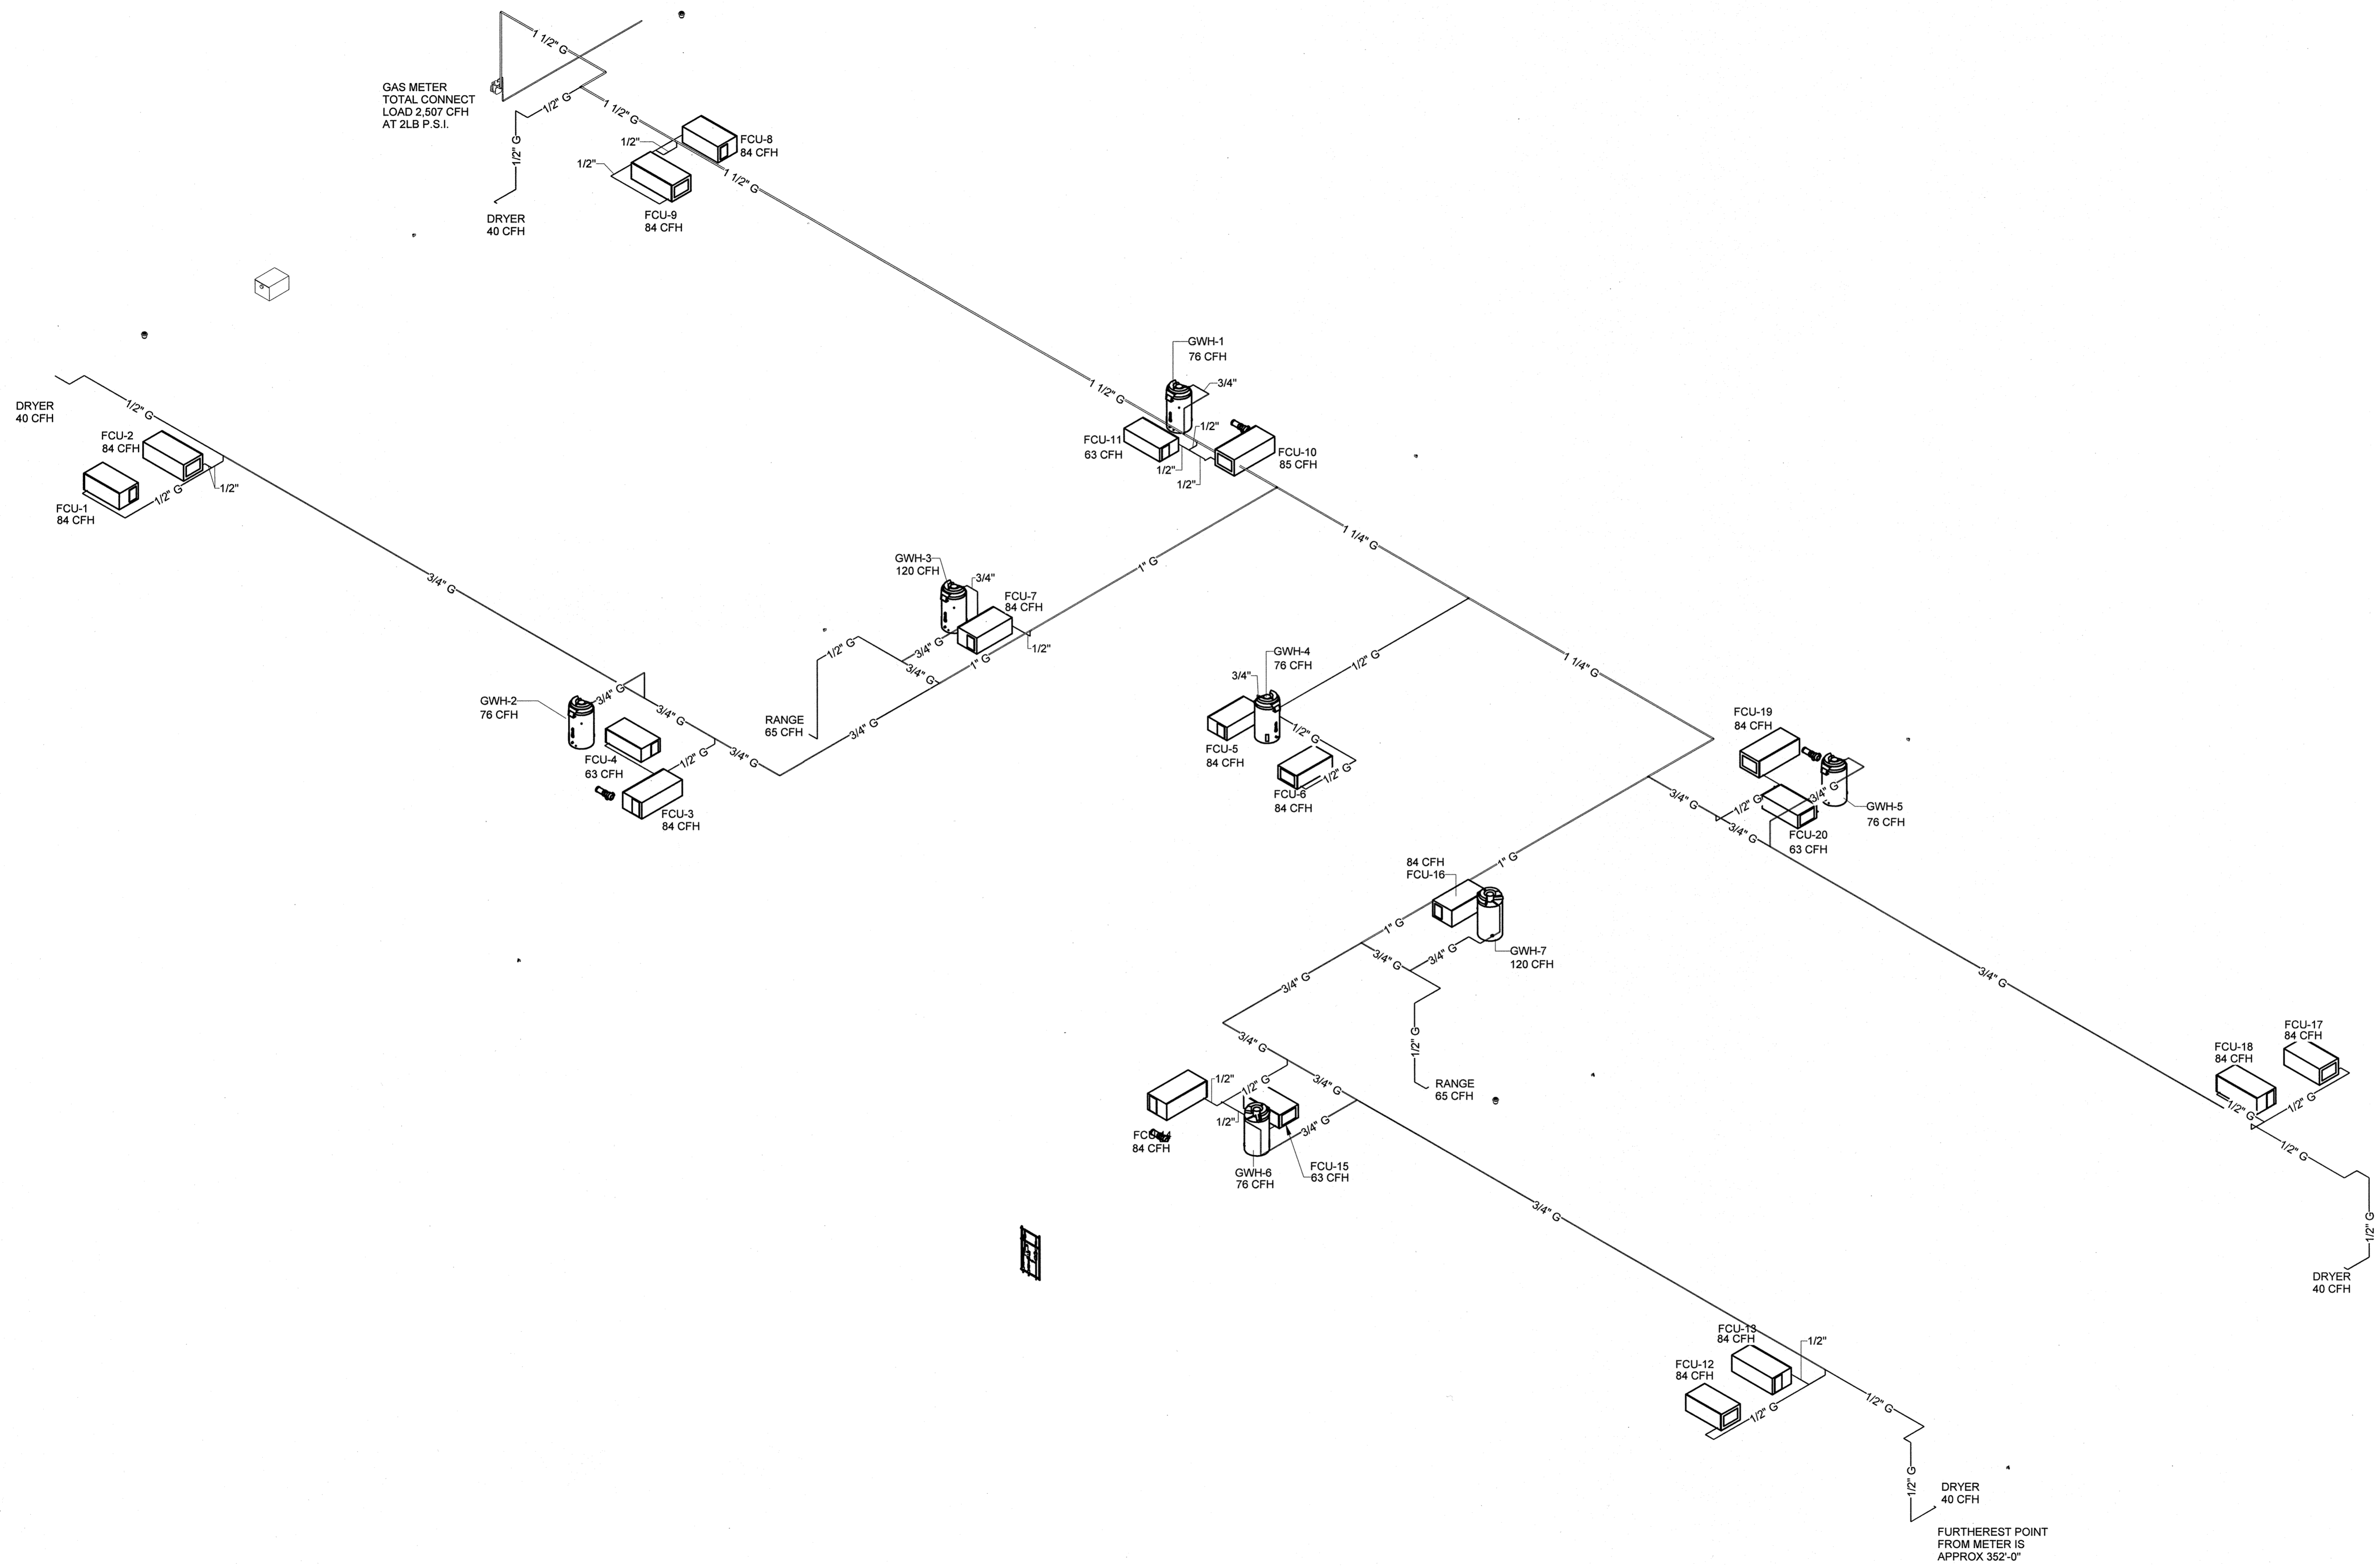

1 PLUMBING RISER DIAGRAM - NATURAL GAS

FURTHEREST POINT FROM METER IS APPROX 352'-0"

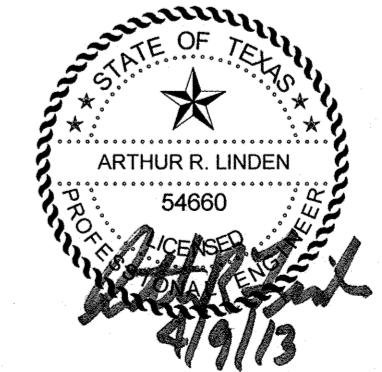

REDDING LINDEN BARR
 CONSULTING ENGINEERS
 801 TRAVIS, SUITE 2000
 HOUSTON, TEXAS 77002
 PH: 713.237.9800
 FAX: 713.237.9801
 TEXAS REGISTERED ENGINEERING FIRM F- 3113

OPTIMUM CARE
SUGAR LAND, TEXAS



Revision Schedule		
#	Date	Description

Project No.
 PLBG RISER DIAGRAM - NATURAL GAS
 Sheet No.

P2.03